




**SANITARY & DOMESTIC WATER RISER DIAGRAM**  
NOT TO SCALE

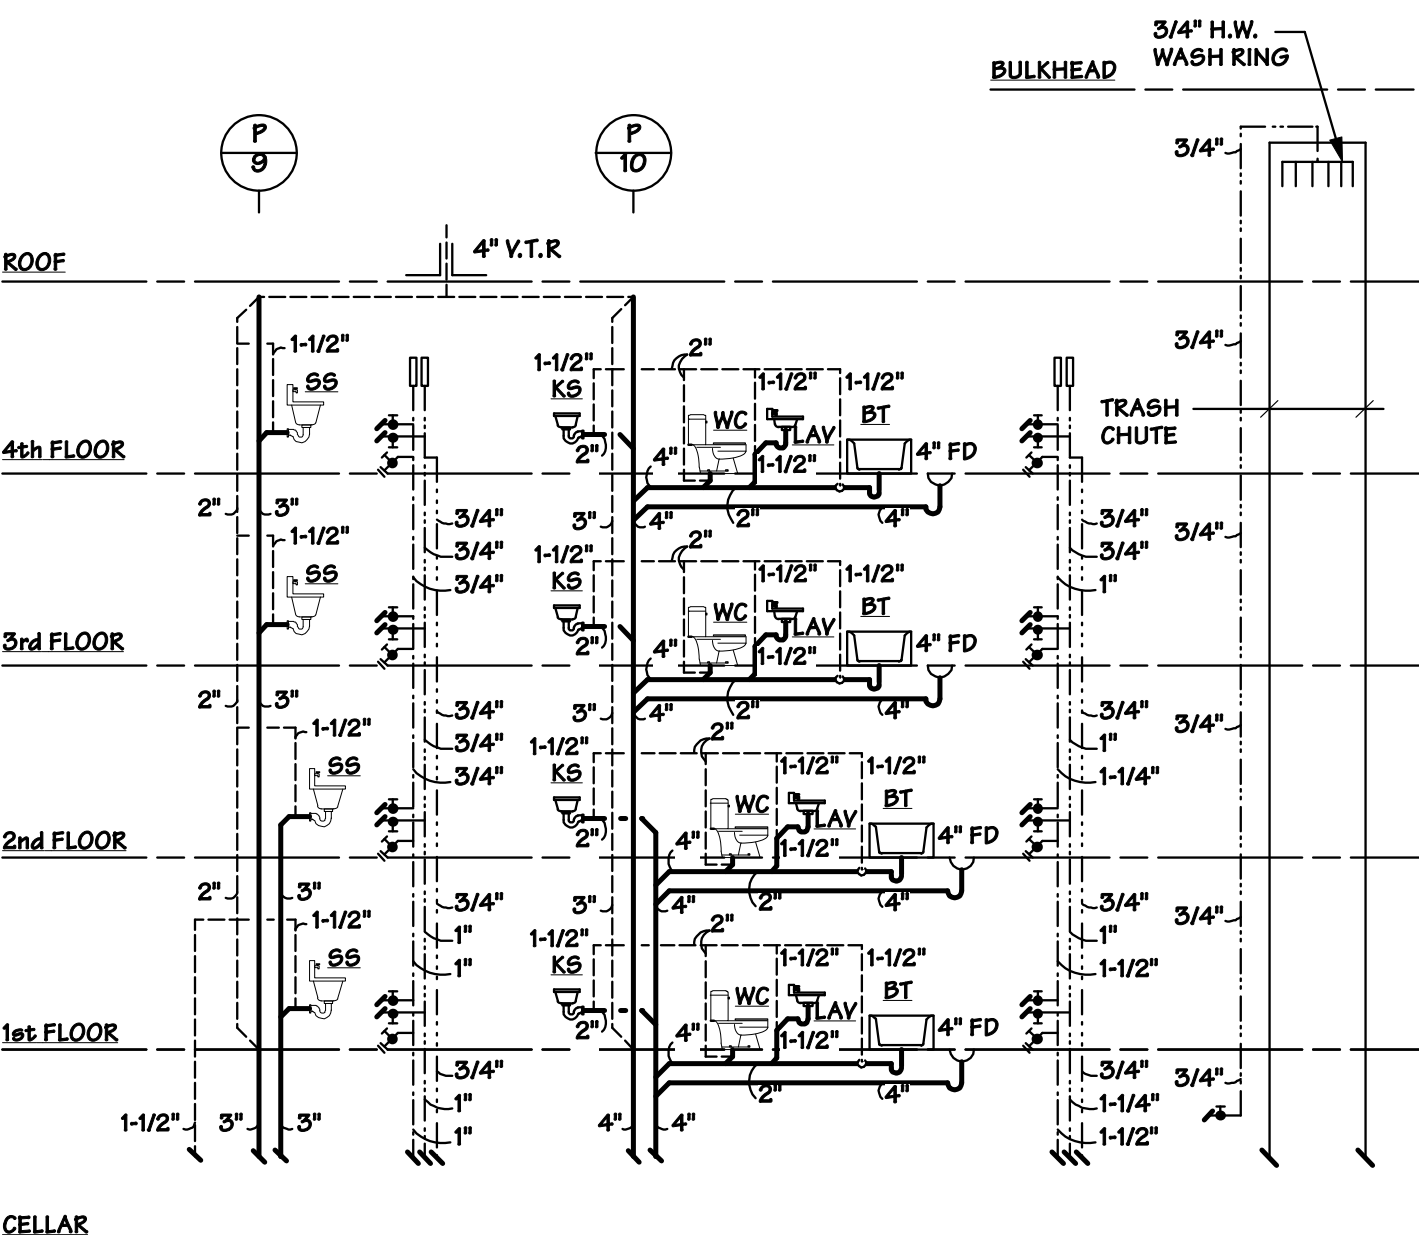


**SANITARY & DOMESTIC WATER RISER DIAGRAM**  
NOT TO SCALE

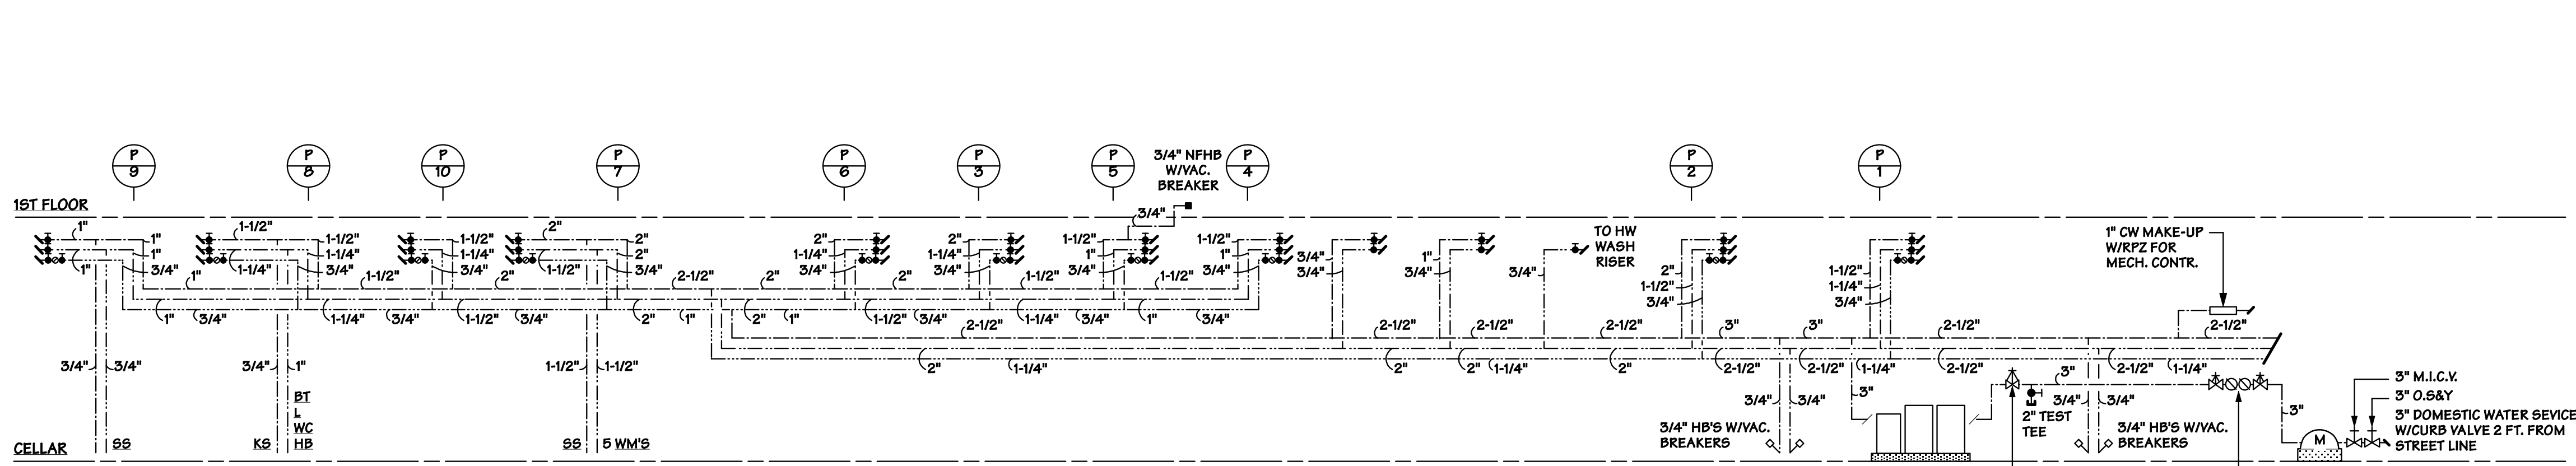


**DOMESTIC WATER CONNECTION DIAGRAM**  
NOT TO SCALE

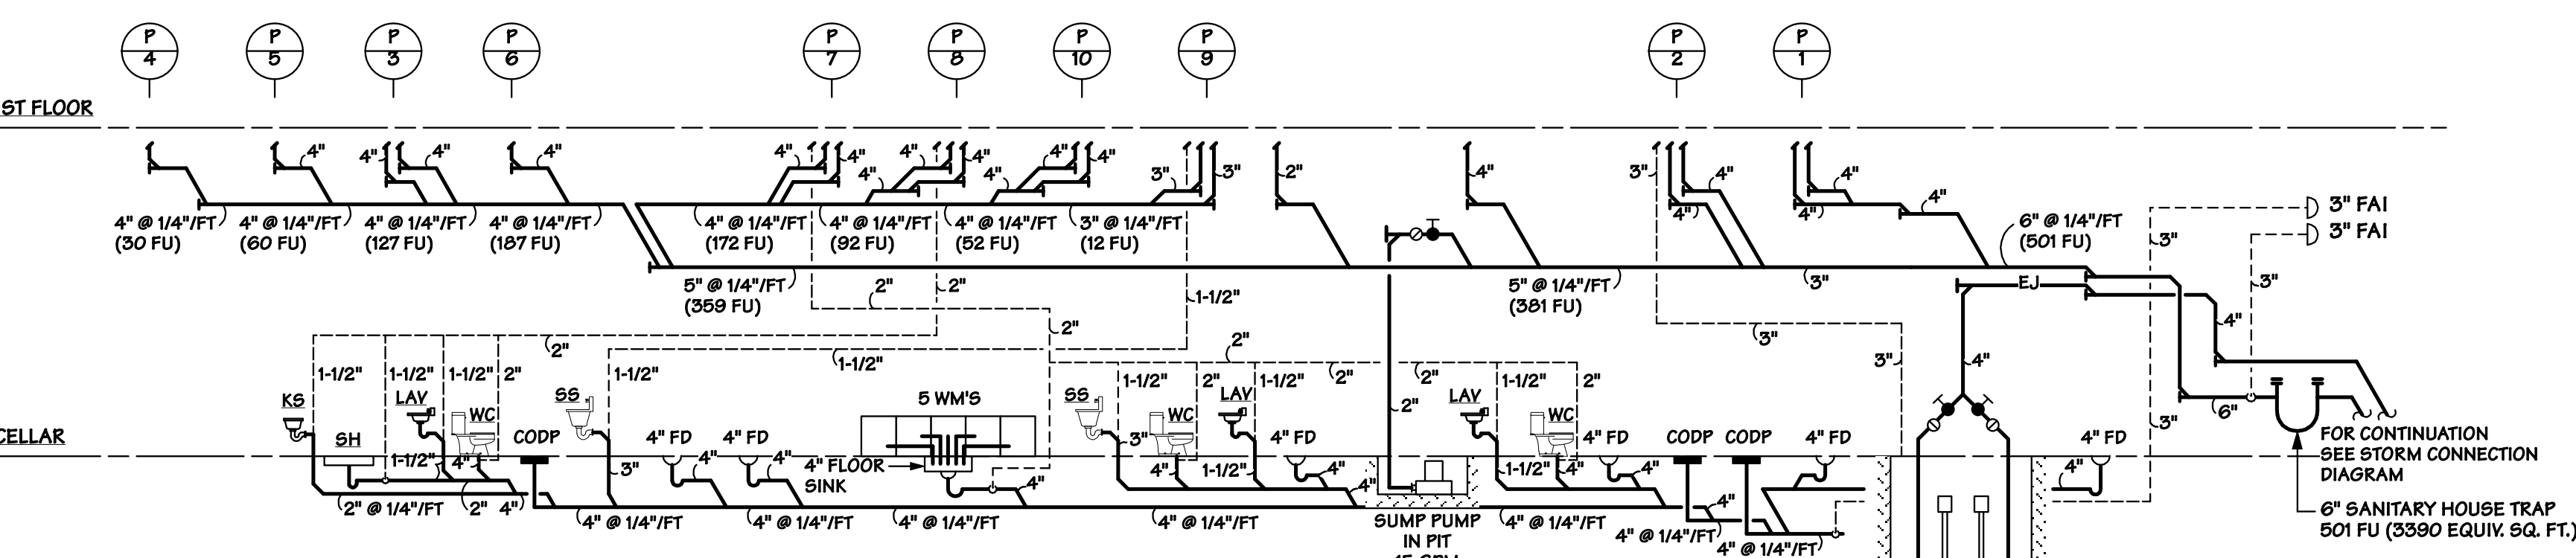


**SANITARY CONNECTION DIAGRAM**  
NOT TO SCALE

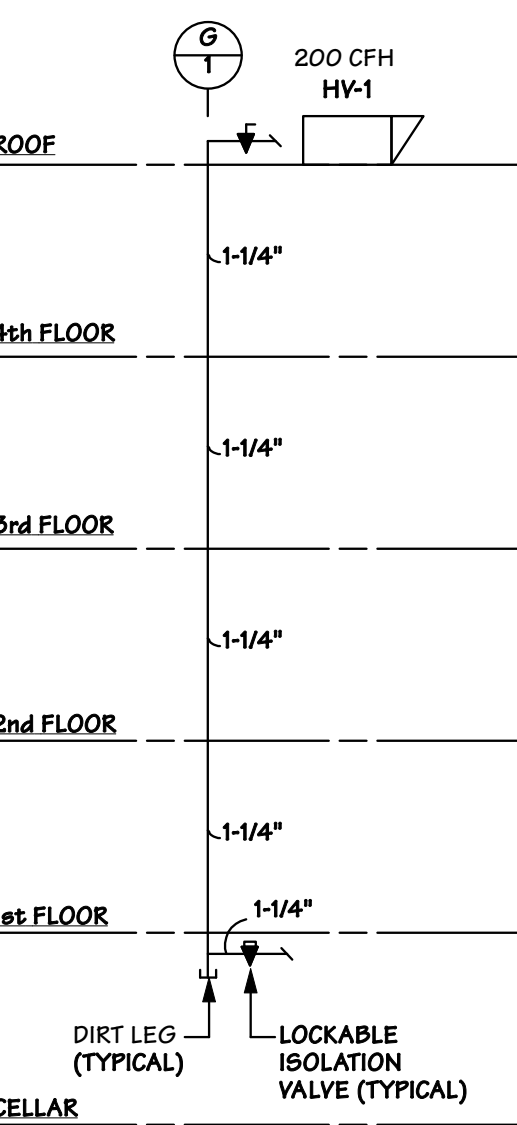


**GAS RISER DIAGRAM**  
NOT TO SCALE

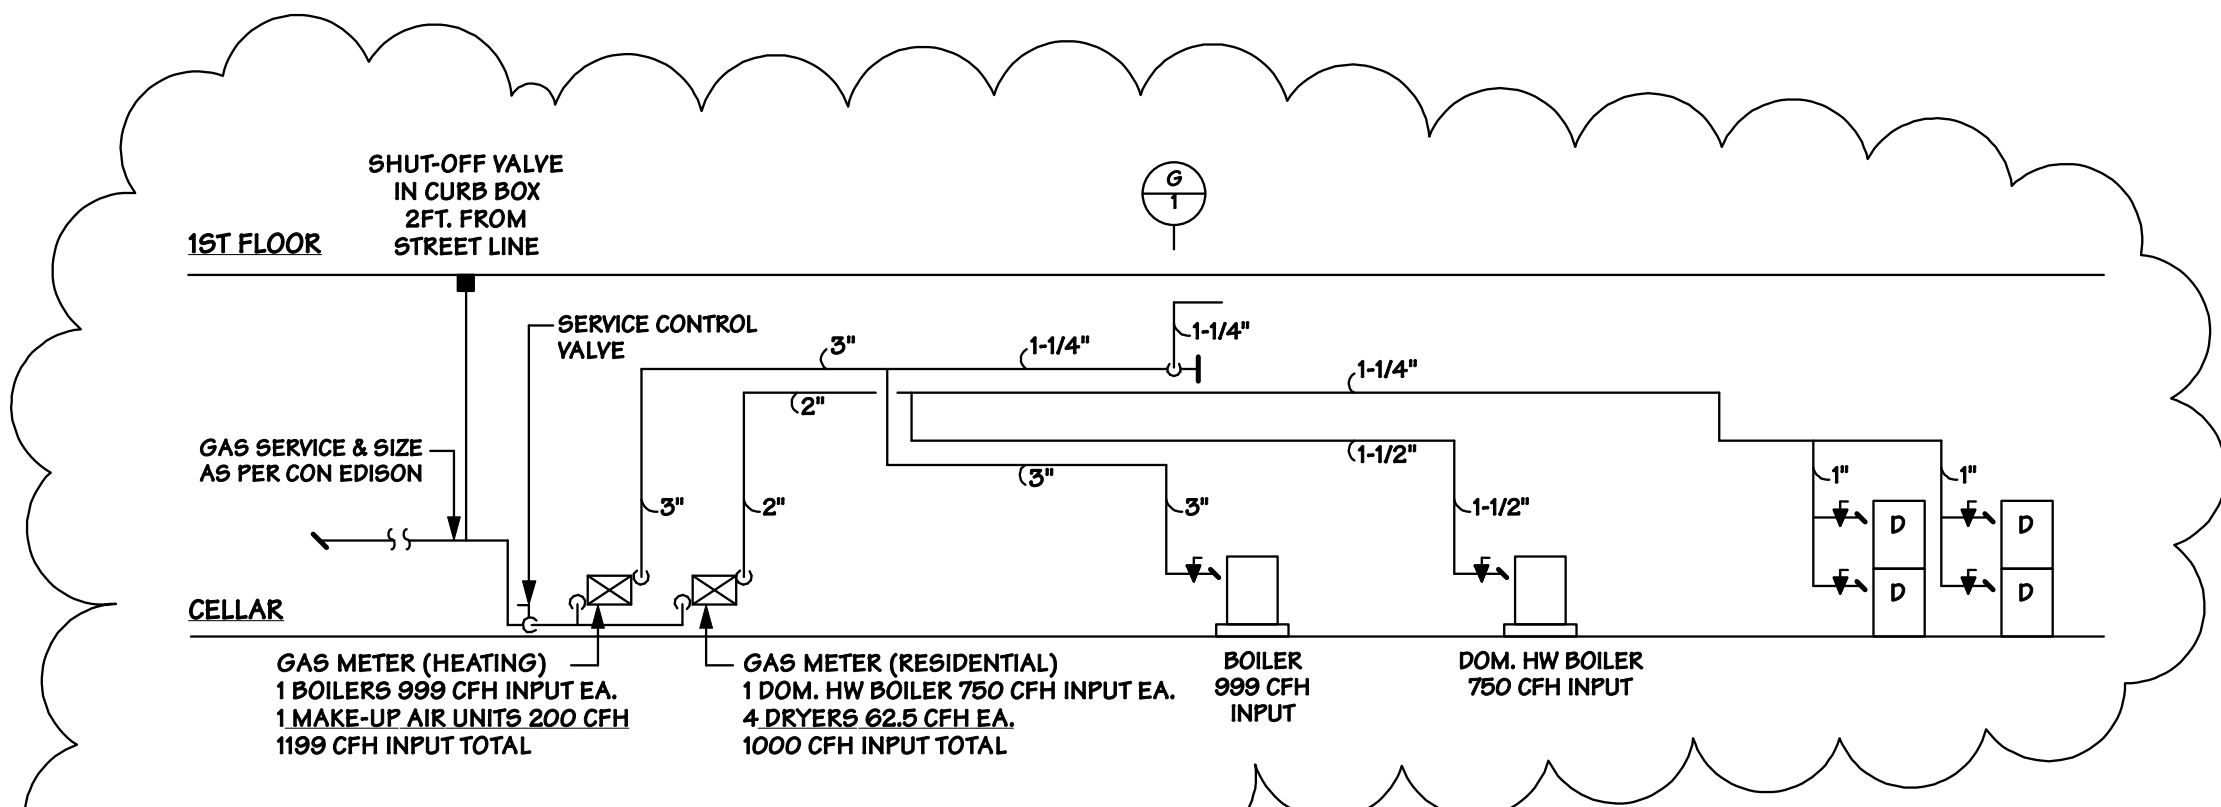

**GAS CONNECTION DIAGRAM**  
NOT TO SCALE

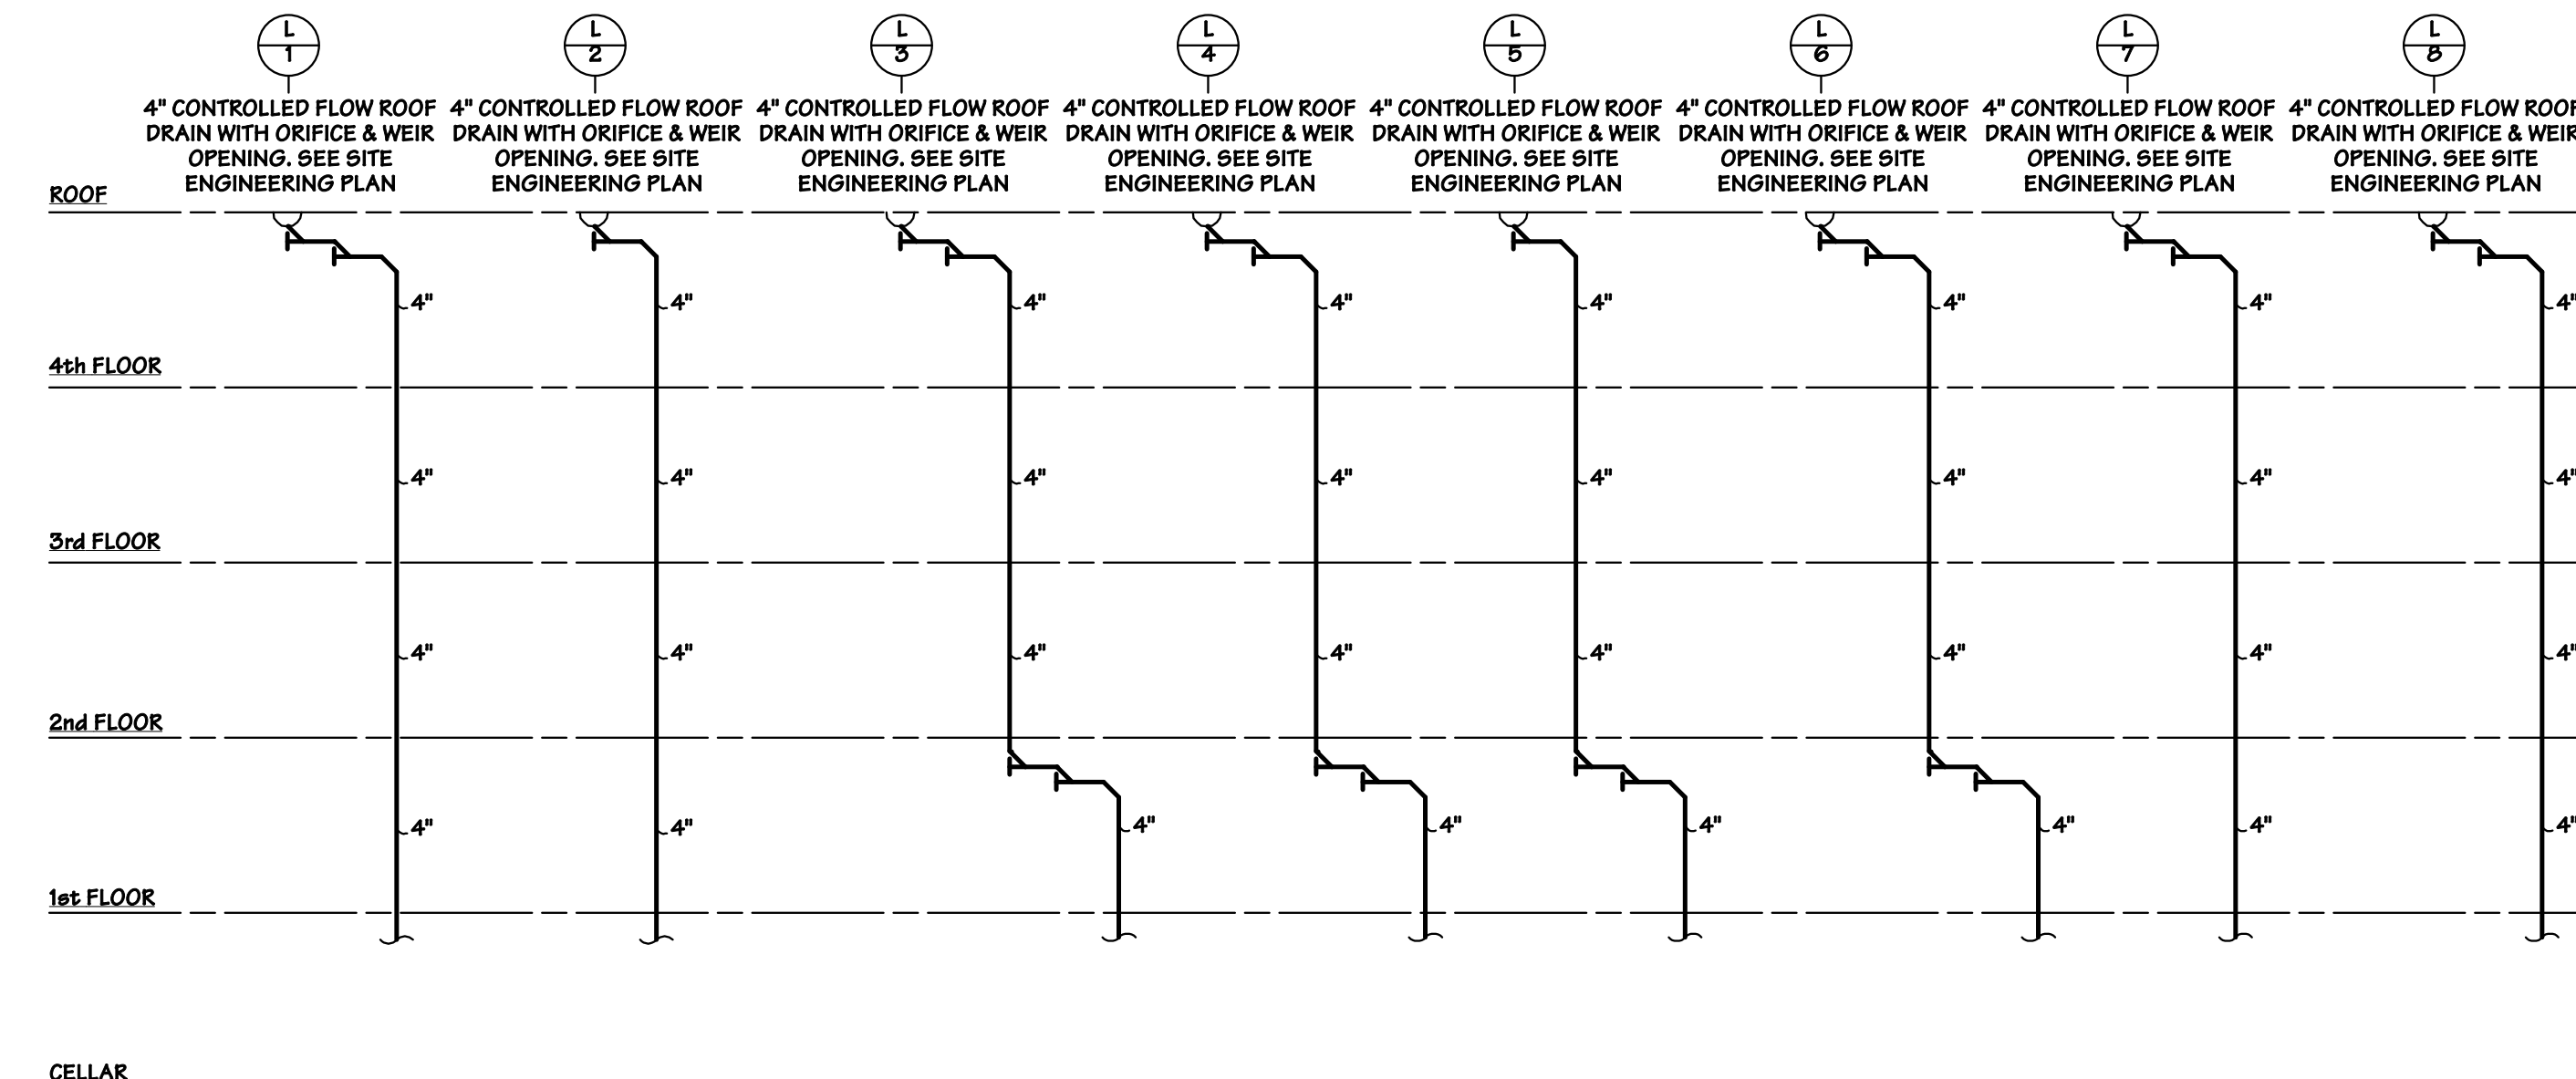

**STORM RISER DIAGRAM**  
NOT TO SCALE

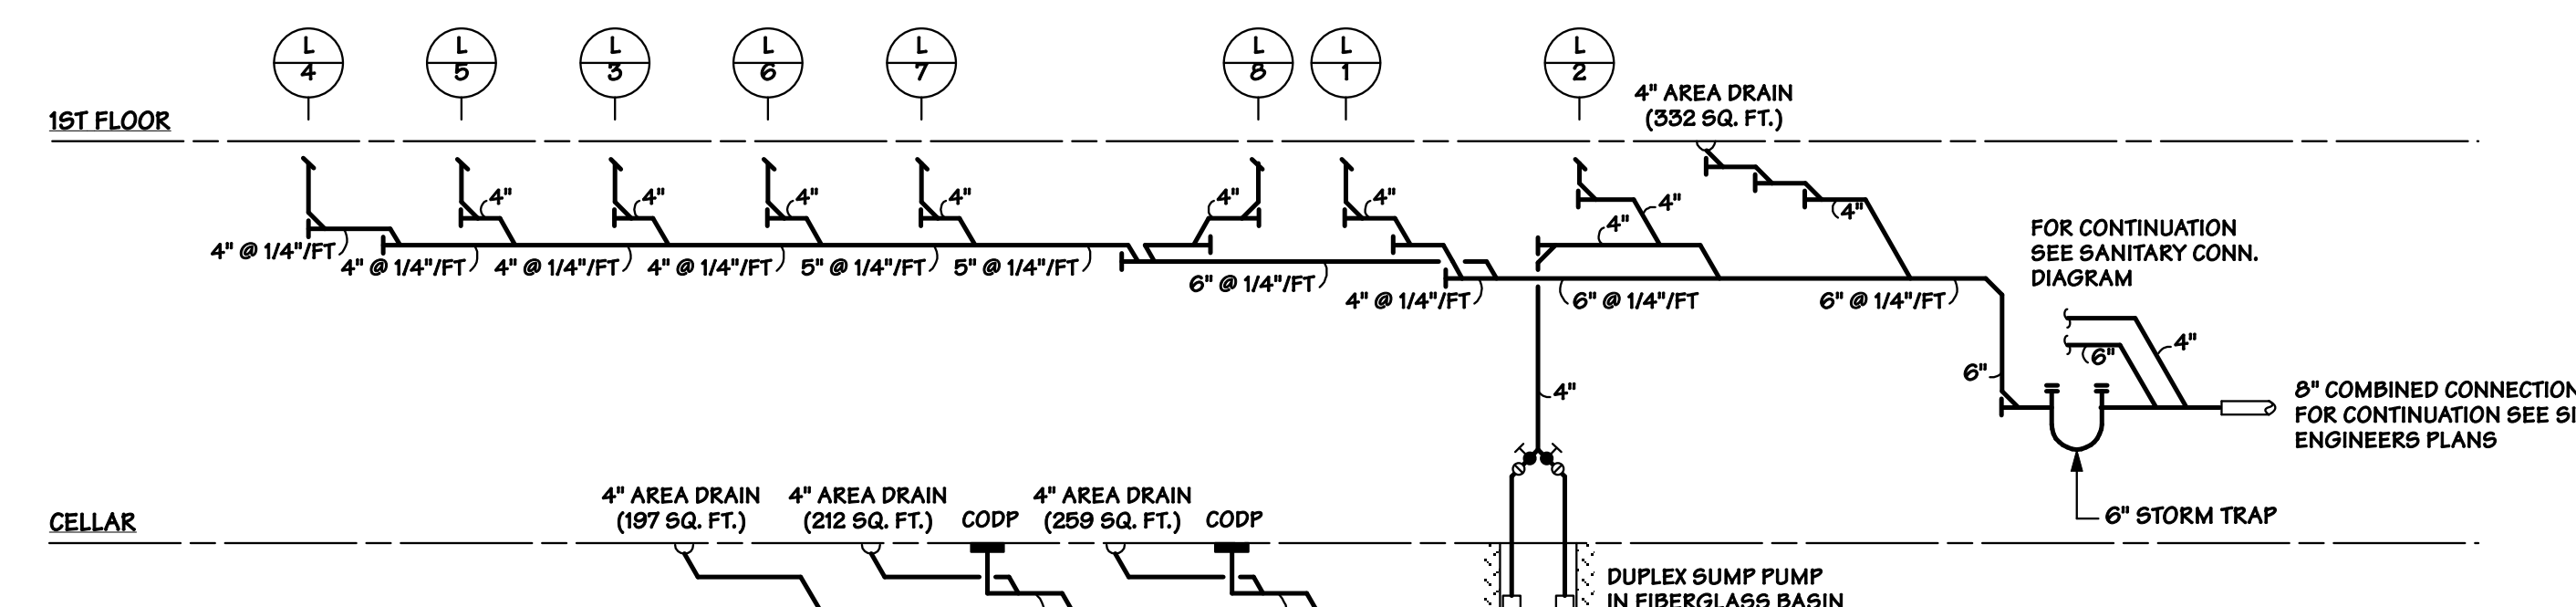

**STORM CONNECTION DIAGRAM**  
NOT TO SCALE

DATE	ISSUES / REVISIONS
2 APR 2007	REVISE BOILER ROOM
10 APR 2006	FOR CONSTRUCTION
18 MAR 2006	ARCHITECTURAL REVISIONS
18 JAN 2006	HPD REVIEW
21 SEPT 2005	ISSUED TO BID, NOT FOR CONSTRUCTION
27 JUN 2005	ISSUED TO CONSULTANTS

Architect:  
**EDELMAN SULTAN KNOX WOOD/ARCHITECTS LLP**  
100 Lafayette Street, Suite 204, New York, NY 10013  
tel: 212-431-4901 fax: 212-226-9598

Mechanical Engineer:  
**ROBERT SILMAN ASSOCIATES ENGINEERS**  
88 University Place, New York, NY 10003  
tel: 212-620-7970 fax: 212-620-8157

Mechanical Engineer:  
**ABRAHAM JOSELOW, P.E., P.C.**  
45 West 34th St., Suite 1101 New York, NY 10001  
tel: 212-736-2584 fax: 212-736-0241

**1301-1321 LOUIS NINE BOULEVARD**  
BRONX, NEW YORK 10459  
WHEDCO  
50 East 158th Street  
Bronx, NY 10452

**PLUMBING RISER AND CONNECTION DIAGRAMS**

PROJECT NO.: 05012	SCALE: AS NOTED
SEAL:	BY: YL CHECK: PJ
	DATE: 20 SEPT 2005
	DWG NO.: